

Minutes of Prebid meeting for tender

C-050-34/Tenders/01/2012 dt. 25 Apr. 2012

Prebid meeting was scheduled at HPC building conference hall on 04 May 12 at 1130 hrs for tender Enquiry No. C-050-34/Tenders/01/2012 dt. 25 Apr. 2012 "PA, Audio visual and CCTV System". The following Members were present

1. Dr. Surya
2. Dr. Mukhopadhyay
3. Shri. Jaishankar (consultant)
4. Shri. S M Hendre
5. Shri. SMD Jeelani
6. Shri A K Saxena
7. Shri. R M Bankar
8. Shri. S R Nirgude
9. Smt. S U Athale
10. Smt. A R Seshagiri

The following representative's from various vendors/companies participated in the same (Attendance sheet enclosed).

Company Name	Person
1. HCL	Mr. Reno Kurian
2. Siemens	Mr. Abhishek Dhody
3. Shalaka Infra-Tech	Mr. Niranjana Pailwan
4. Enkay Technologies	Mr. Girish Zunzunwala
5. Godrej	Mr. Kanchankumar
6. Discreet	Mr. Alok Parmar
7. Plus	Mr. Shani Varghese
8. Genesis	Mr. Pravin Thakoor

At the ^{outset} committee welcomed all the Vendors/companies participating in the prebid meeting and discussed about the basis of tendered requirement and its roadmap. Further it was mentioned to all the companies to request for any clarification or deviation from the tendered specification subject to:

- a. As far as general requirements of the tender are not compromised &
- b. Agreed by all the participants.

All the technical queries were clarified on the specifications and the following amendments were requested and the committee has agreed to the same.

1. In the list of approved makes for Microphones, 'Beyerdynamics' make is included and accepted by the committee.
2. In the list of approved makes for speakers, 'Tannoy' make is included and accepted by the committee.
3. In the list of approved makes for 3500 DLP Projector, 'Hitachi' make is included and accepted by the committee.
4. In the list of approved makes for 10000 ANSI Full HD (Main Projector), 'Barco' make is included and accepted by the committee.
5. In the list of approved makes for LED Displays, 'Panasonic' make is included and 'JVC' make is deleted and accepted by the committee.
6. In Technical specification point No. 25 is " SITC of Flame-guard-FRLS PVC speaker cable for sub-woofers: 4 core, 4 Sq. mm, 56 strands, each strand of 0.3 mm thickness.
7. In Technical specifications point No. 70.a is added as follows (for BOQ 70.a)

70.a SITC of HDMI Audio De-embedder

Max Data Rate –up to 2.25 Gbps.

HDCP Compliant.

HDTV Compatible.

HDMI Support – HDMI (V.1.4 with ARC, HDMI uncompressed Audio Channels, Dolby TrueHD, DTS-HD).

Auto Format Detection – Digital RGB or YPbPr.

INPUT: 1 HDMI connector.

OUTPUTS: 1 HDMI connector, 1 TOSLINK® optical digital audio Connector, 1 S/PDIF digital audio on an RCA connector, 1 unbalanced Stereo audio on a 3.5mm mini connector.

CONTROLS: Audio source select button.

INDICATOR LEDES: ON, IN, OUT ..

Approved Makes: Extron / Kramer.

8. In BOQ item List point No. 70.a is added as follows

70.a Supply, Installation, Testing and Commissioning of HDMI Audio De-embedder as required and as per detailed specifications mentions. **Quantity 01.**

9. BOQ. Item Nos 71 and 72 are to be quoted for rate only and are given as additional optional items. This will not be considered in evaluation of commercial bid.

10. Other queries

a. Query raised on input details (Transmitters and Receivers) are confirmed to be as per the Video distribution diagram, and relevant items are included in the BOQ. No addition is envisaged.

b. In the case of HDMI cables, the requirement of repeaters was raised for lengths beyond 5 m. The same will be, as per the vendors selection of equipment, and if repeaters are required, then they are deemed to be included in the quoted rates of the respective items.

c. The Video conferencing system specified in the BOQ item No.71, includes Data Solution Software for PC Connectivity and also includes multi-point connectivity software for connecting 4 (1+3) centres on IP/ISDN.

d. The quantities for BOQ item nos 47, 49 and 50 shall be 10, 10 and 01 respectively.

Clarification on Commercial and Other terms and conditions of the tender

1. EMD will be acceptable from Nationalized bank scheduled bank in the form of BG/DD. And BG should be valid for 180 days, even if mentioned otherwise elsewhere
2. Quote should preferably be in INR (Indian Rupees)
3. EMD will be returned within 90 days or on issue of LOI or whichever is earlier.
4. Manufacturers Authorization Form/ Letter is compulsory.
5. Upon Bidders requests the Sec 5.3 Pre- Qualification is revised on below issues.
 - 5.3 (5) Bidder is preferred to be an ISO 9001:2000/2008 Certificate.
 - 5.3 (6) Bidder should have completed Installation of minimum 3 works with minimum 3 crores nationally or internationally and should be in the AV field for the last 10 years. (Documentary proof, work orders, completion & satisfaction certificates should be given)
6. Consortiums are not accepted.
7. Layout & elevation drawings are annexed with this minutes of meeting.
8. Other queries received from vendors by fax, letters, emails were readout in the pre-bid meeting, discussed & replied as above.
9. Certain queries raised by vendors in written form, were readout and their replies are also included in these minutes accordingly


10. Rest all Specifications & terms and conditions remains as per the published tender.

The meeting ended with thanks to the chair



Dr. Surya 7/5/12


Dr. Mukhopadhyay 7/5/2012

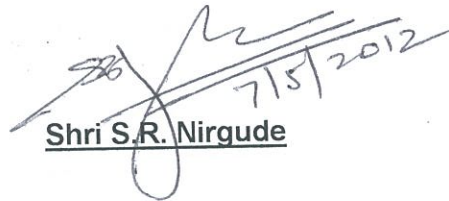
Shri. Jaishankar


Shri S.M.D. Jeelani

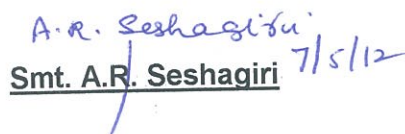

Shri. S M Hendre


Shri A.K. Saxena


Shri R.M. Bankar

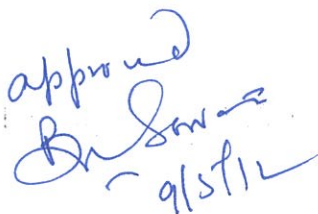

Shri S.R. Nirgude

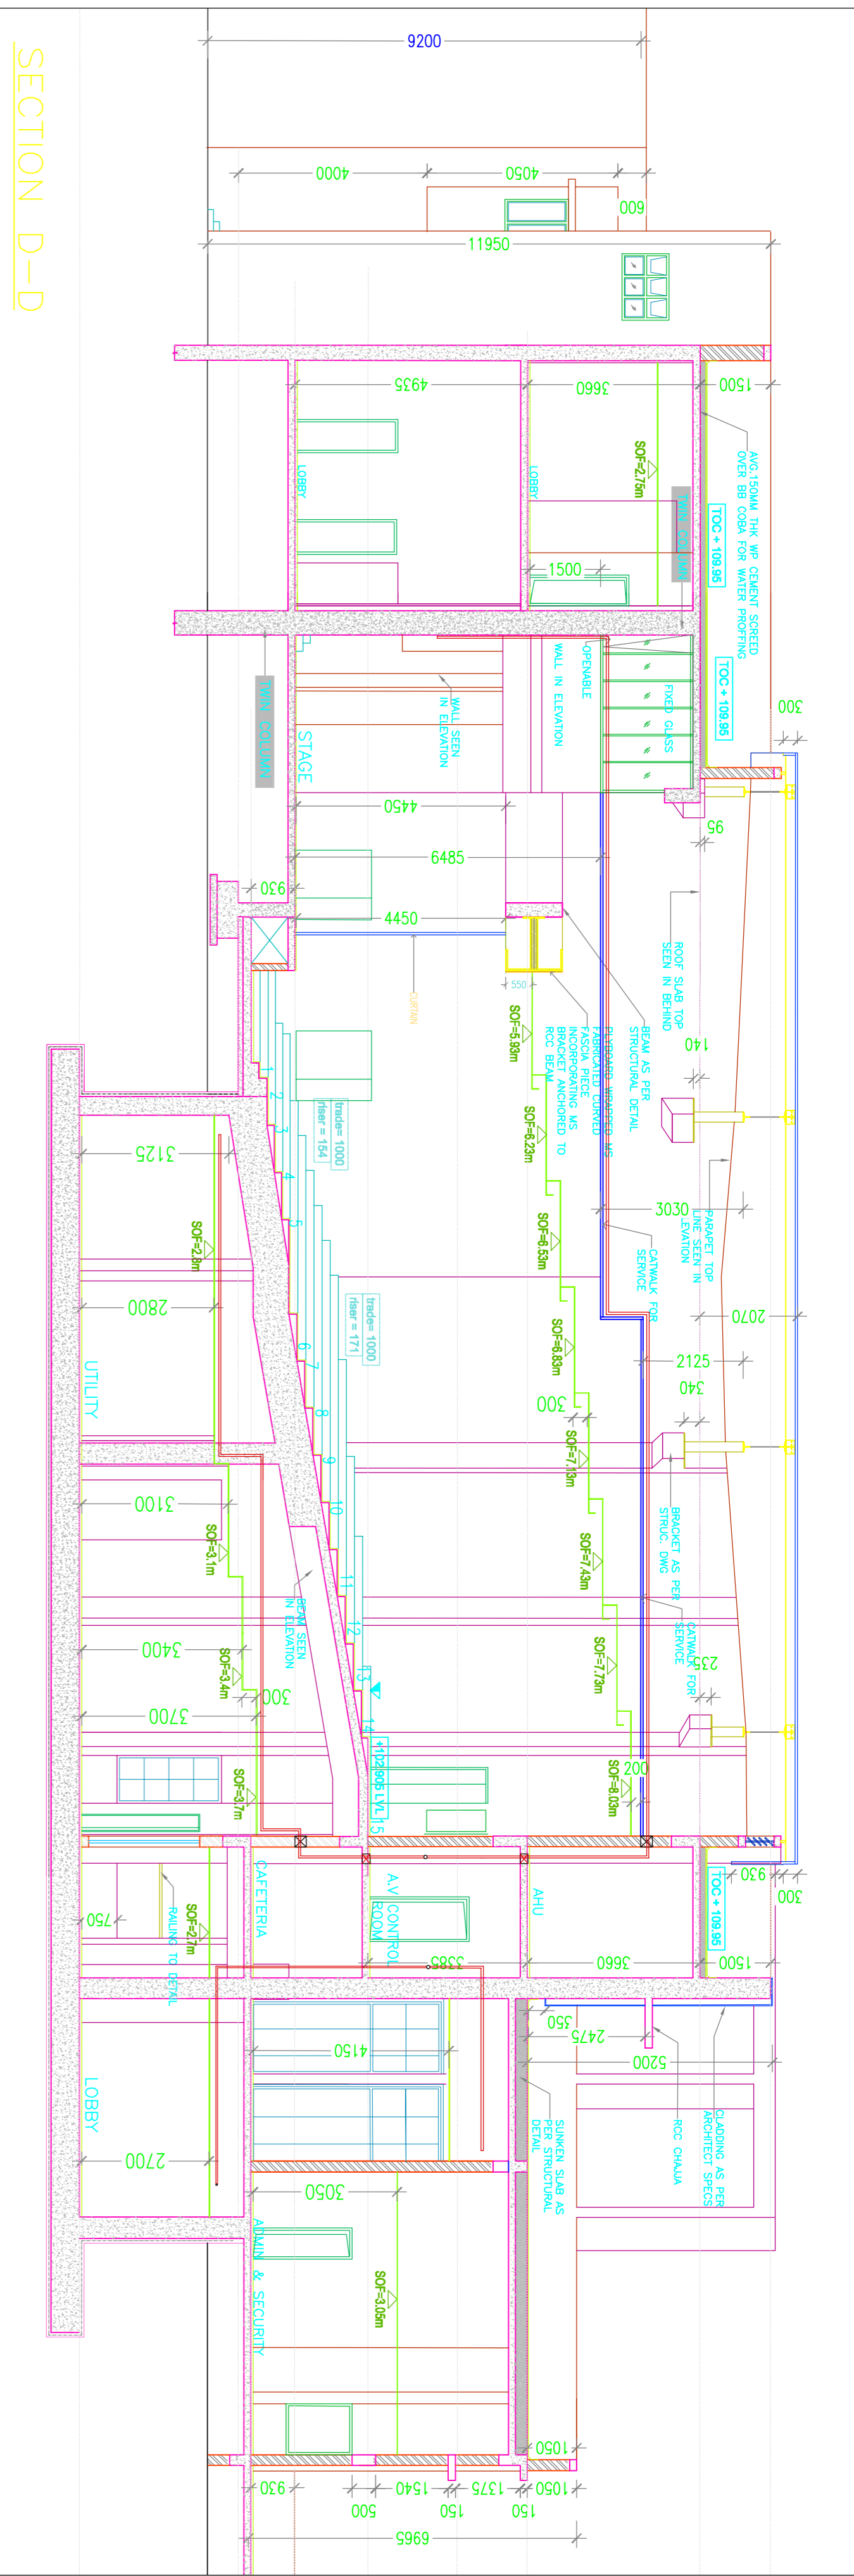

Smt. S.U. Athale


Smt. A.R. Seshagiri 7/5/12

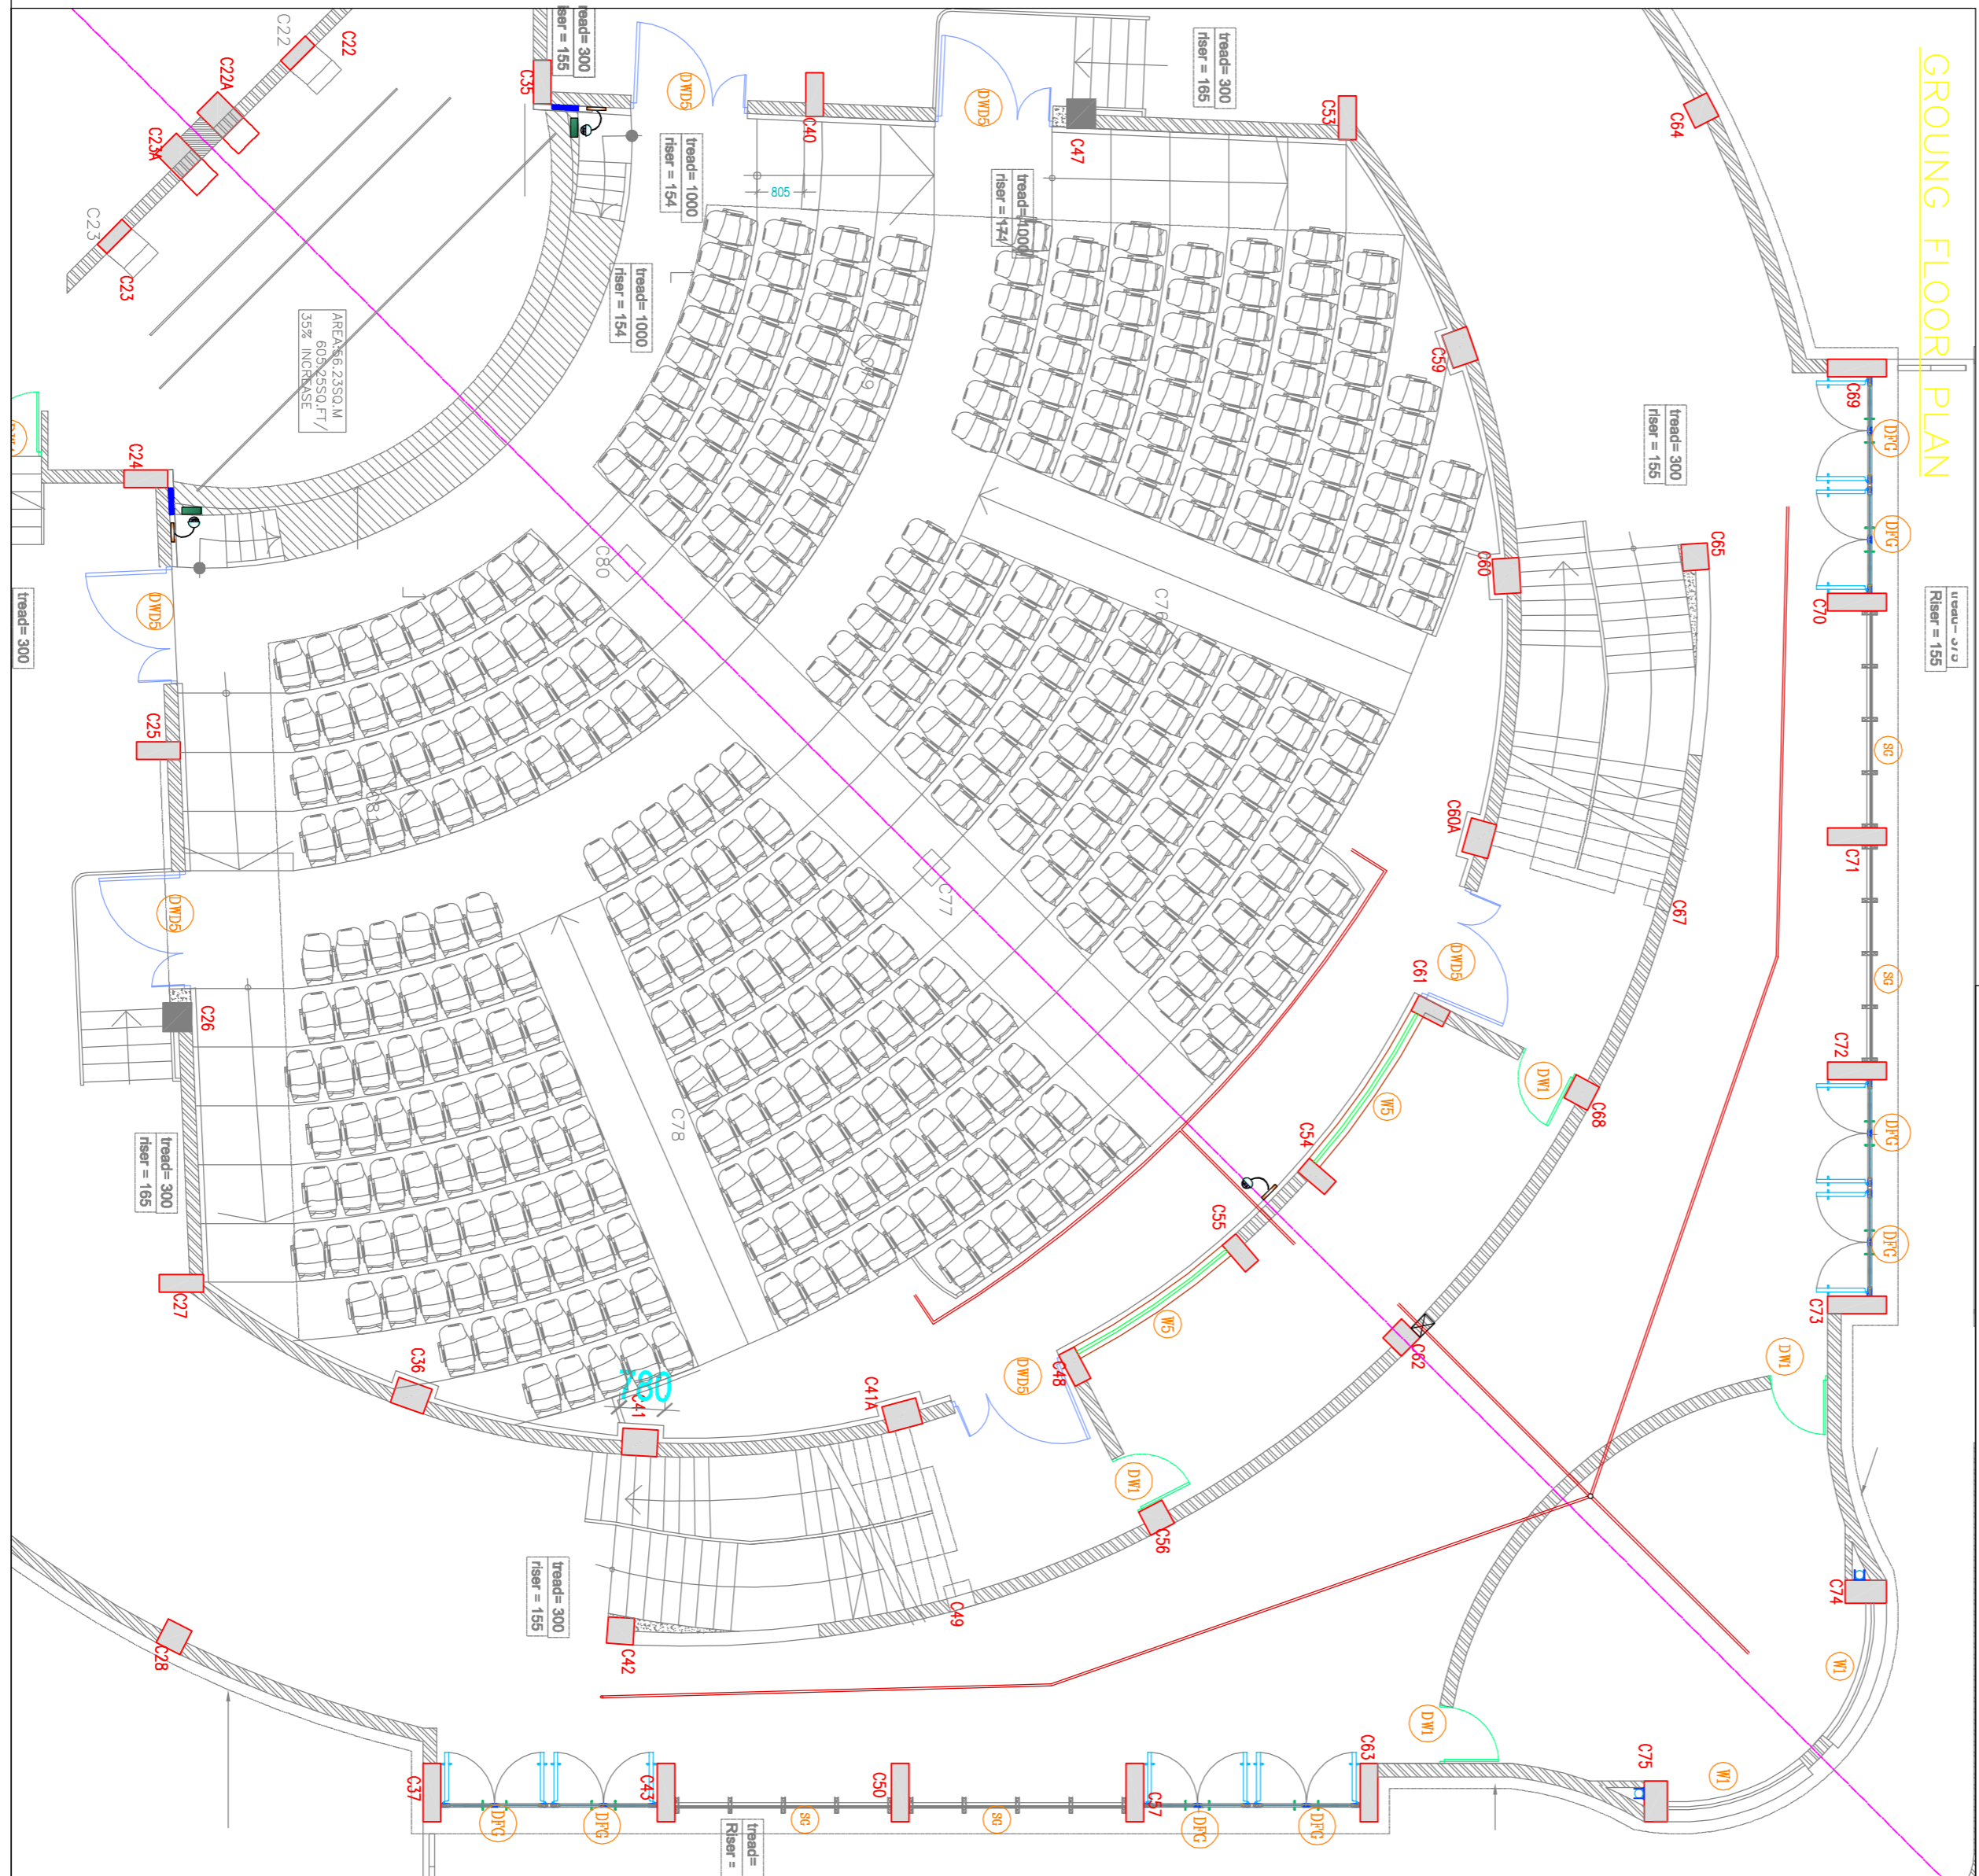
Submitted for Kind approval of Director

Director

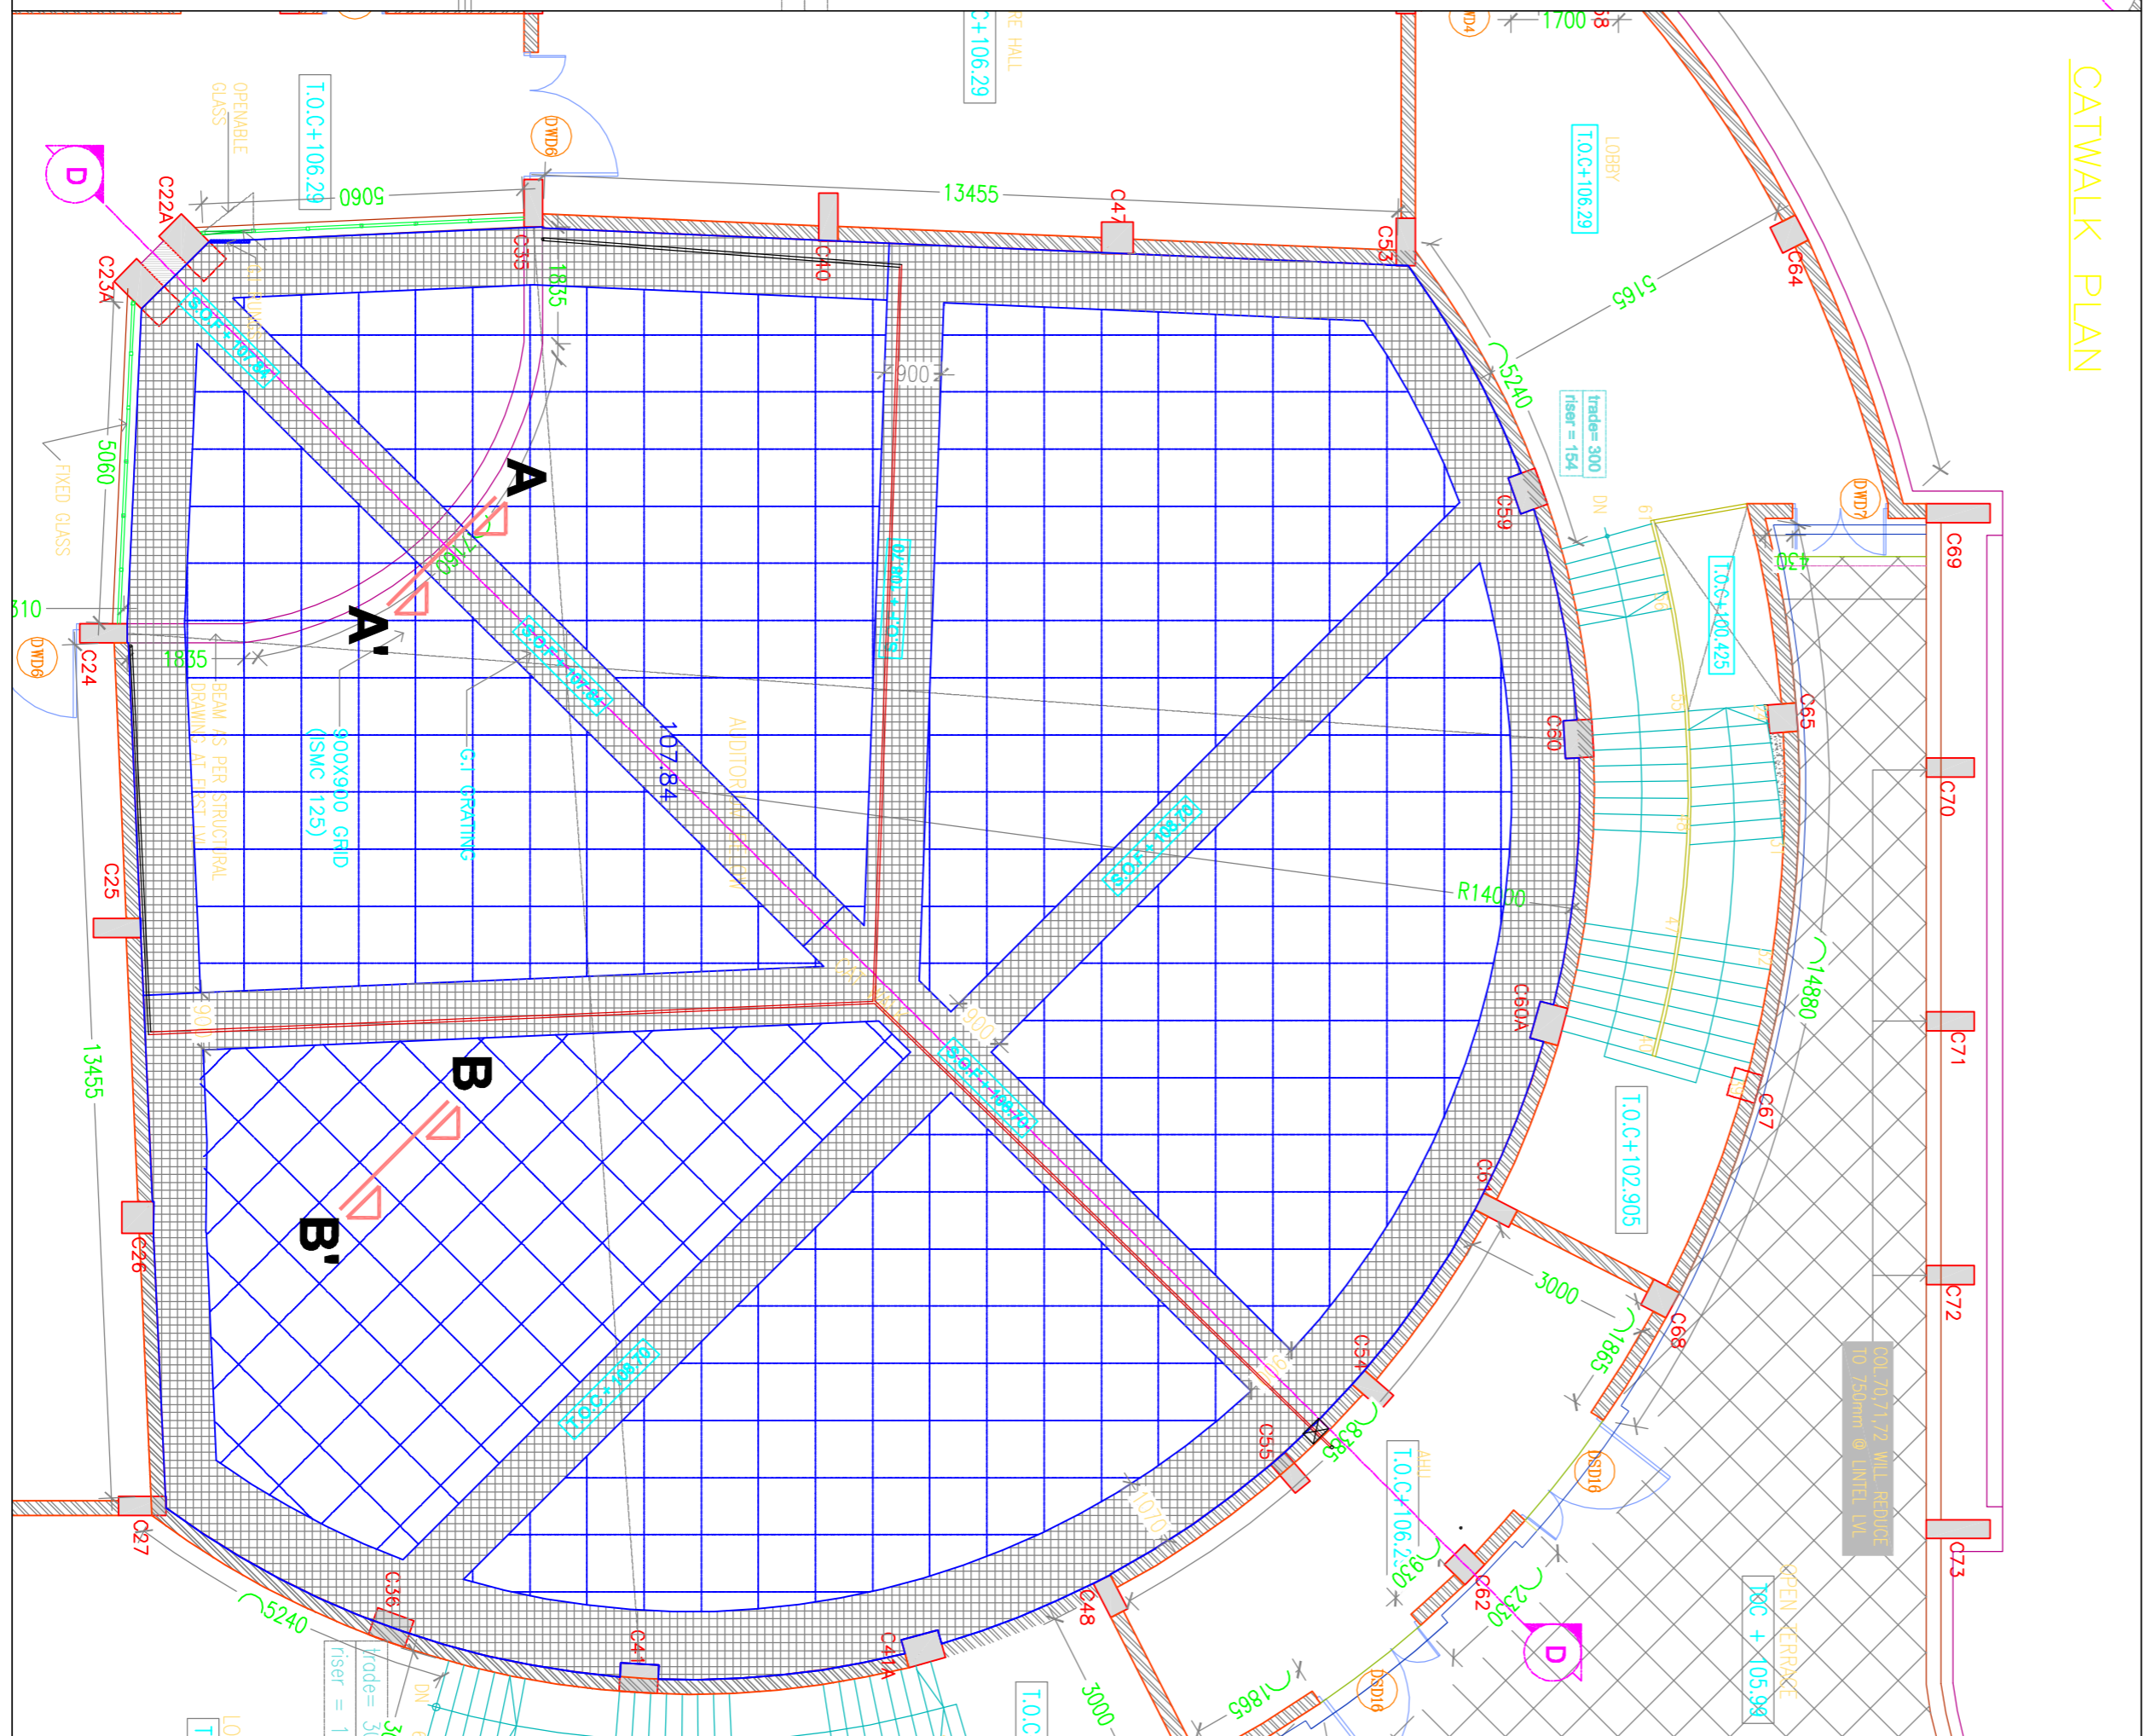

approved
9/5/12



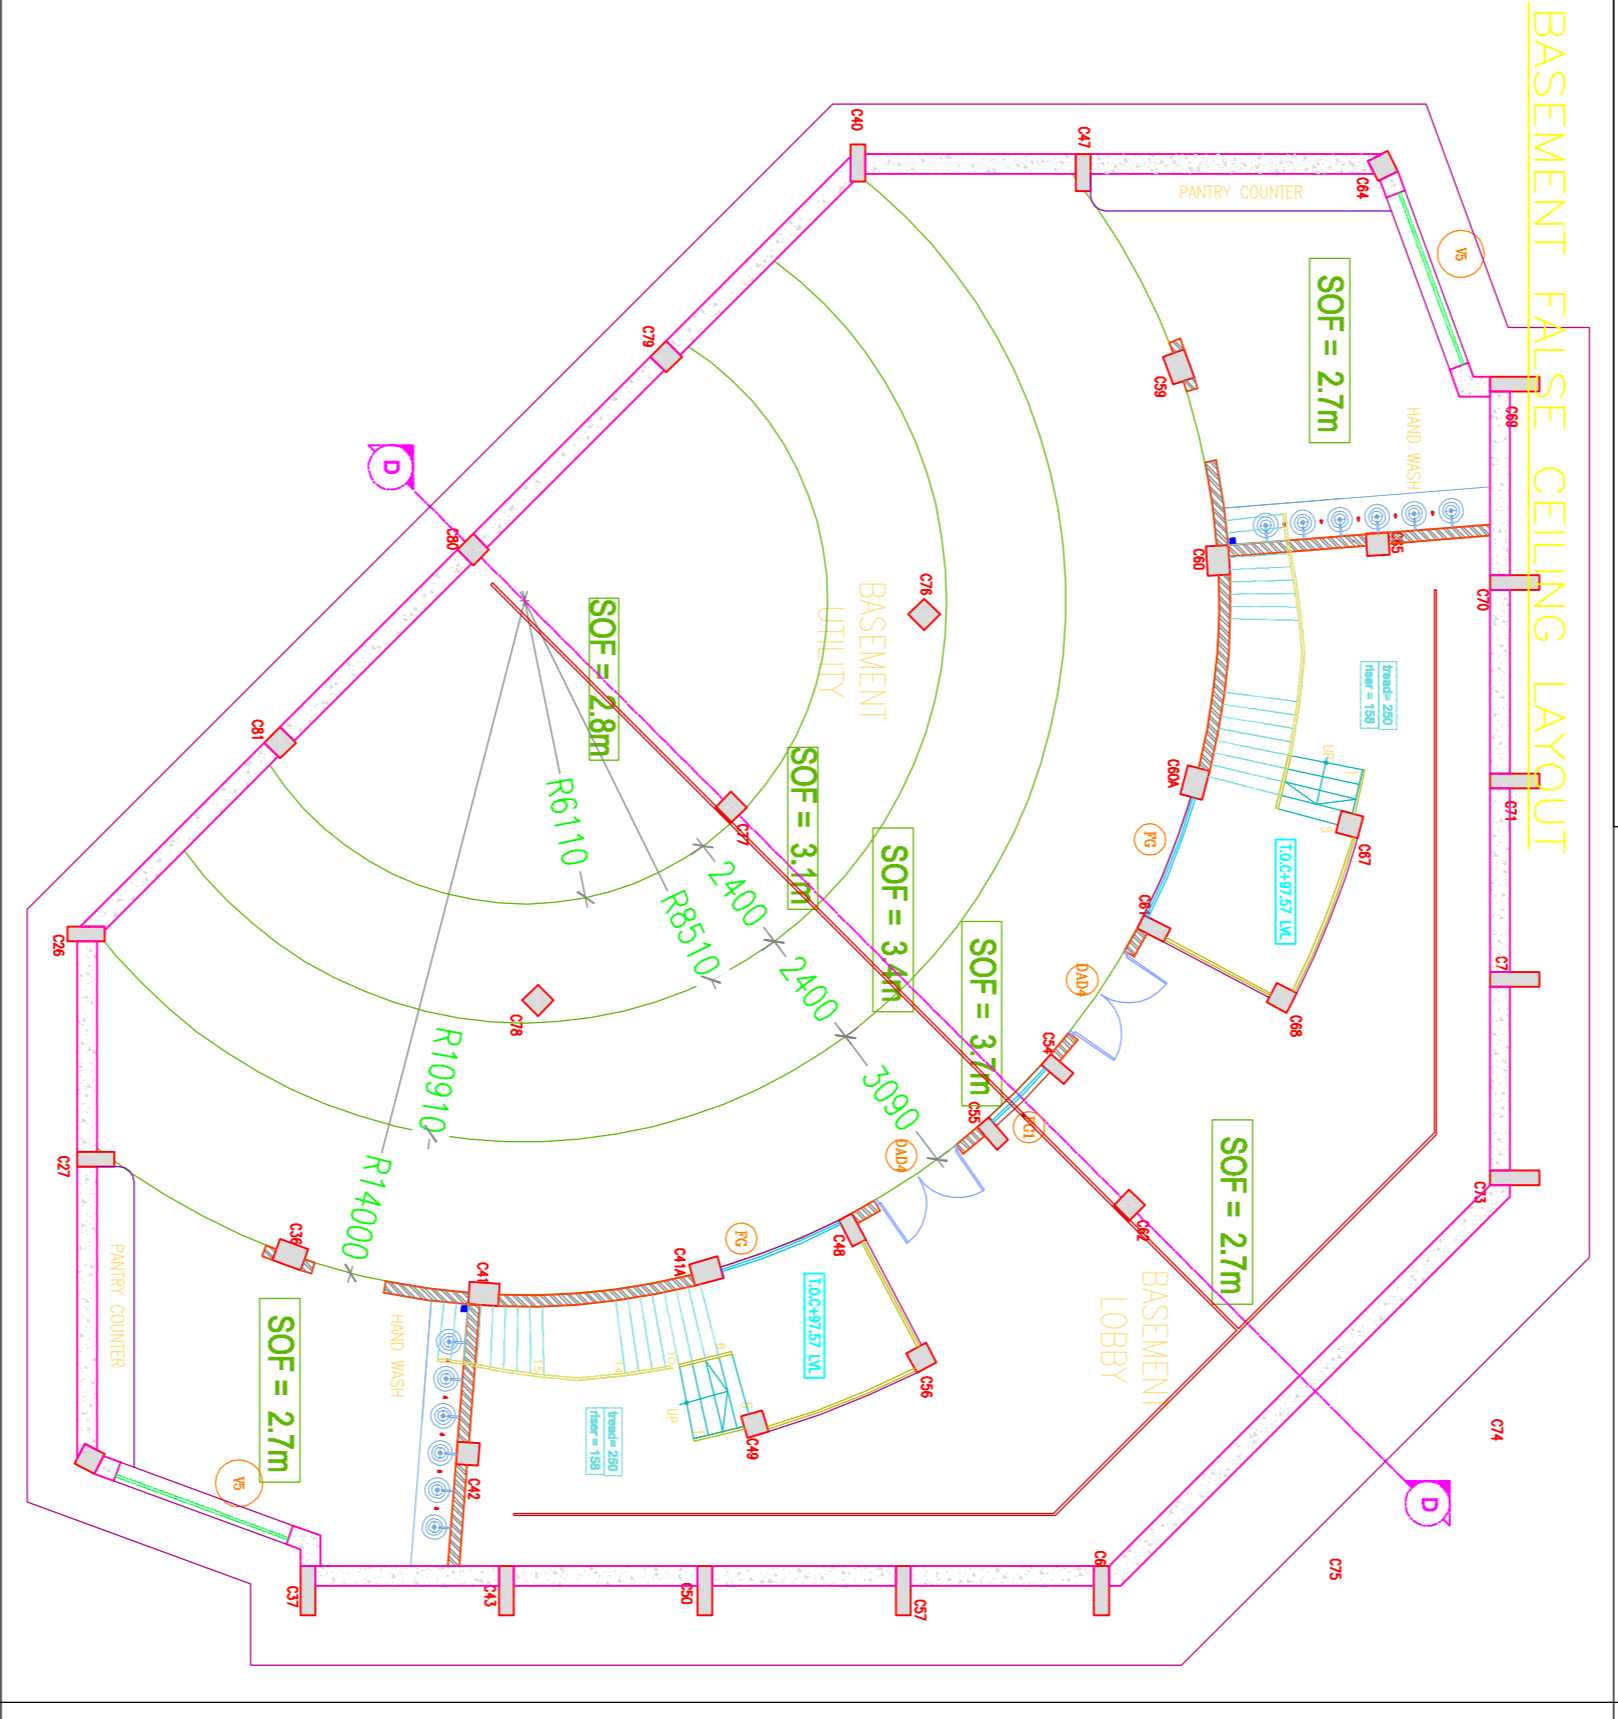
SECTION D-D



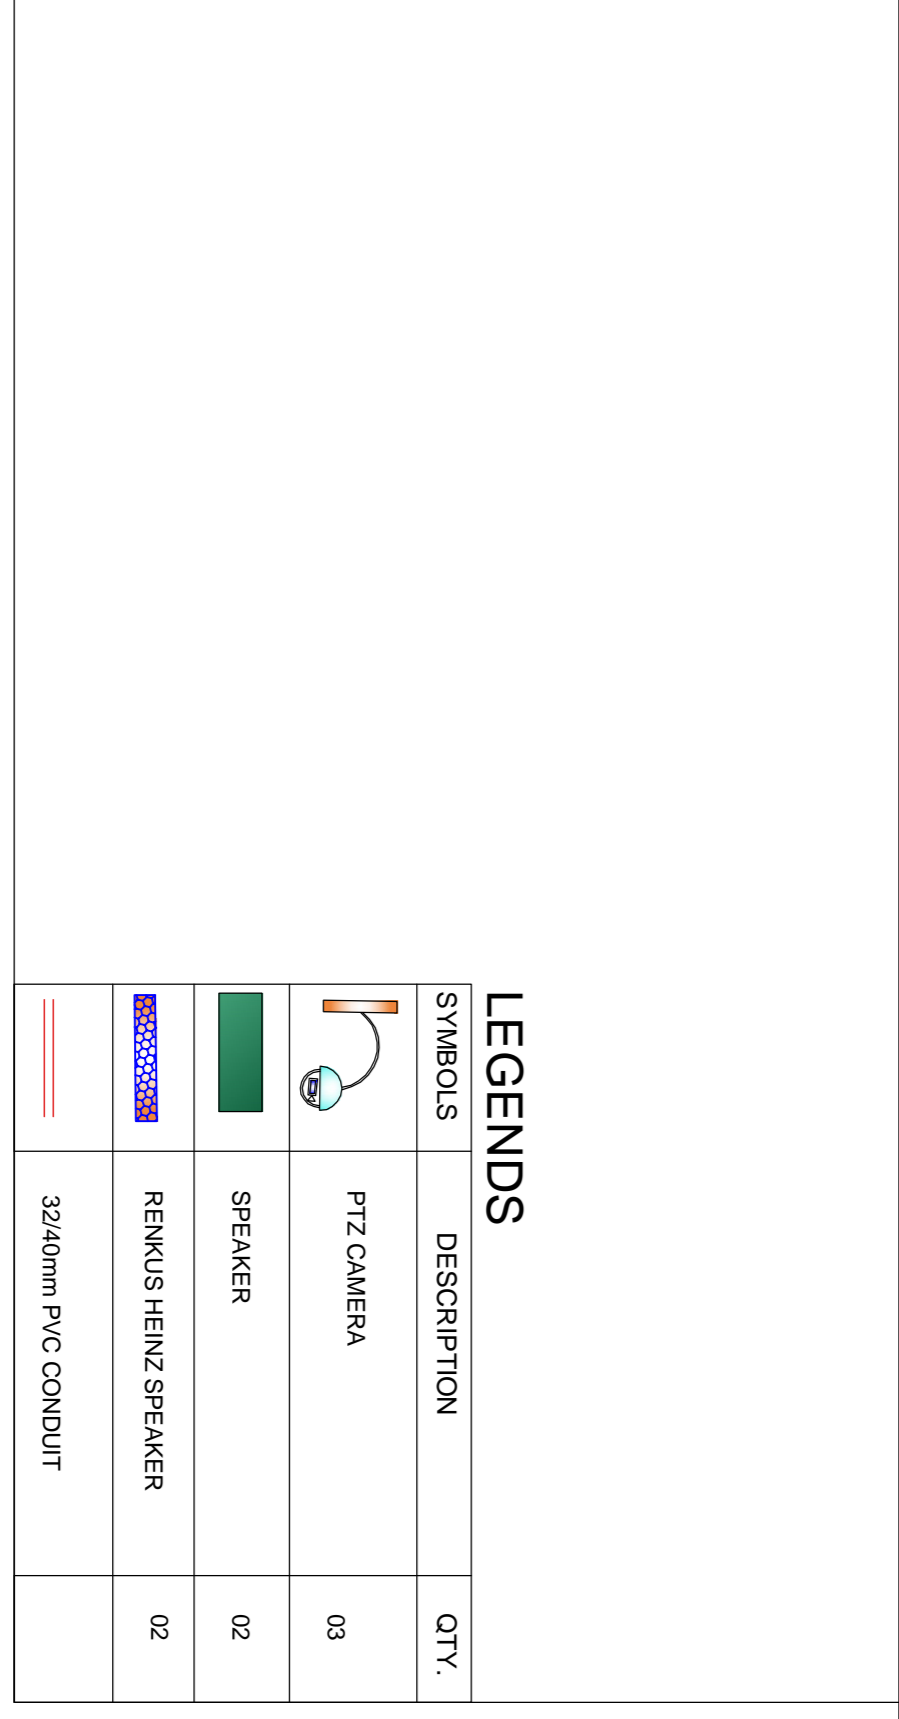
GROUND FLOOR PLAN



CATWALK PLAN



BASEMENT FALSE CEILING LAYOUT



P.A SYSTEM CONDUIT LAYOUT

LEGENDS

SYMBOLS	DESCRIPTION	QTY.
	PTZ CAMERA	03
	SPEAKER	02
	RENNUS HEINZ SPEAKER	02
	32x40mm PVC CONDUIT	

REV.	MODIFICATION	DATE

ARCHIVISTA
ENGINEERING PROJECTS PVT. LTD.
OFFICE NO. 201/202, THIRD FLOOR, SAI EMPIRE
BANER, PUNE - 411 045.
PH. (020) 66294444, FAX. (020) 66294699,
WWW.ARCHIVISTAINdia.COM

PROPOSED COMPLEX FOR CONFERENCE AND LECTURES HALLS - IITM PUNE

STAGE T - TENDER DRAWING

DRAWING TITLE		DRAWING NUMBER		DATE OF FIRST ISSUE		DATE OF REVISION		REVISION	
P.A SYSTEM CONDUIT LAYOUT		IITM_EX_PA.CH_FP_001		18.04.12				R0	
SCALE	1:100	FORMAT	A1	DRAWN BY		CHECKED BY	IITM_EX_PA.CH_FP_001		
DATE OF FIRST ISSUE	18.04.12	REFERENCE DRAWING NUMBER		DATE OF REVISION					

REV.	MODIFICATION	DATE

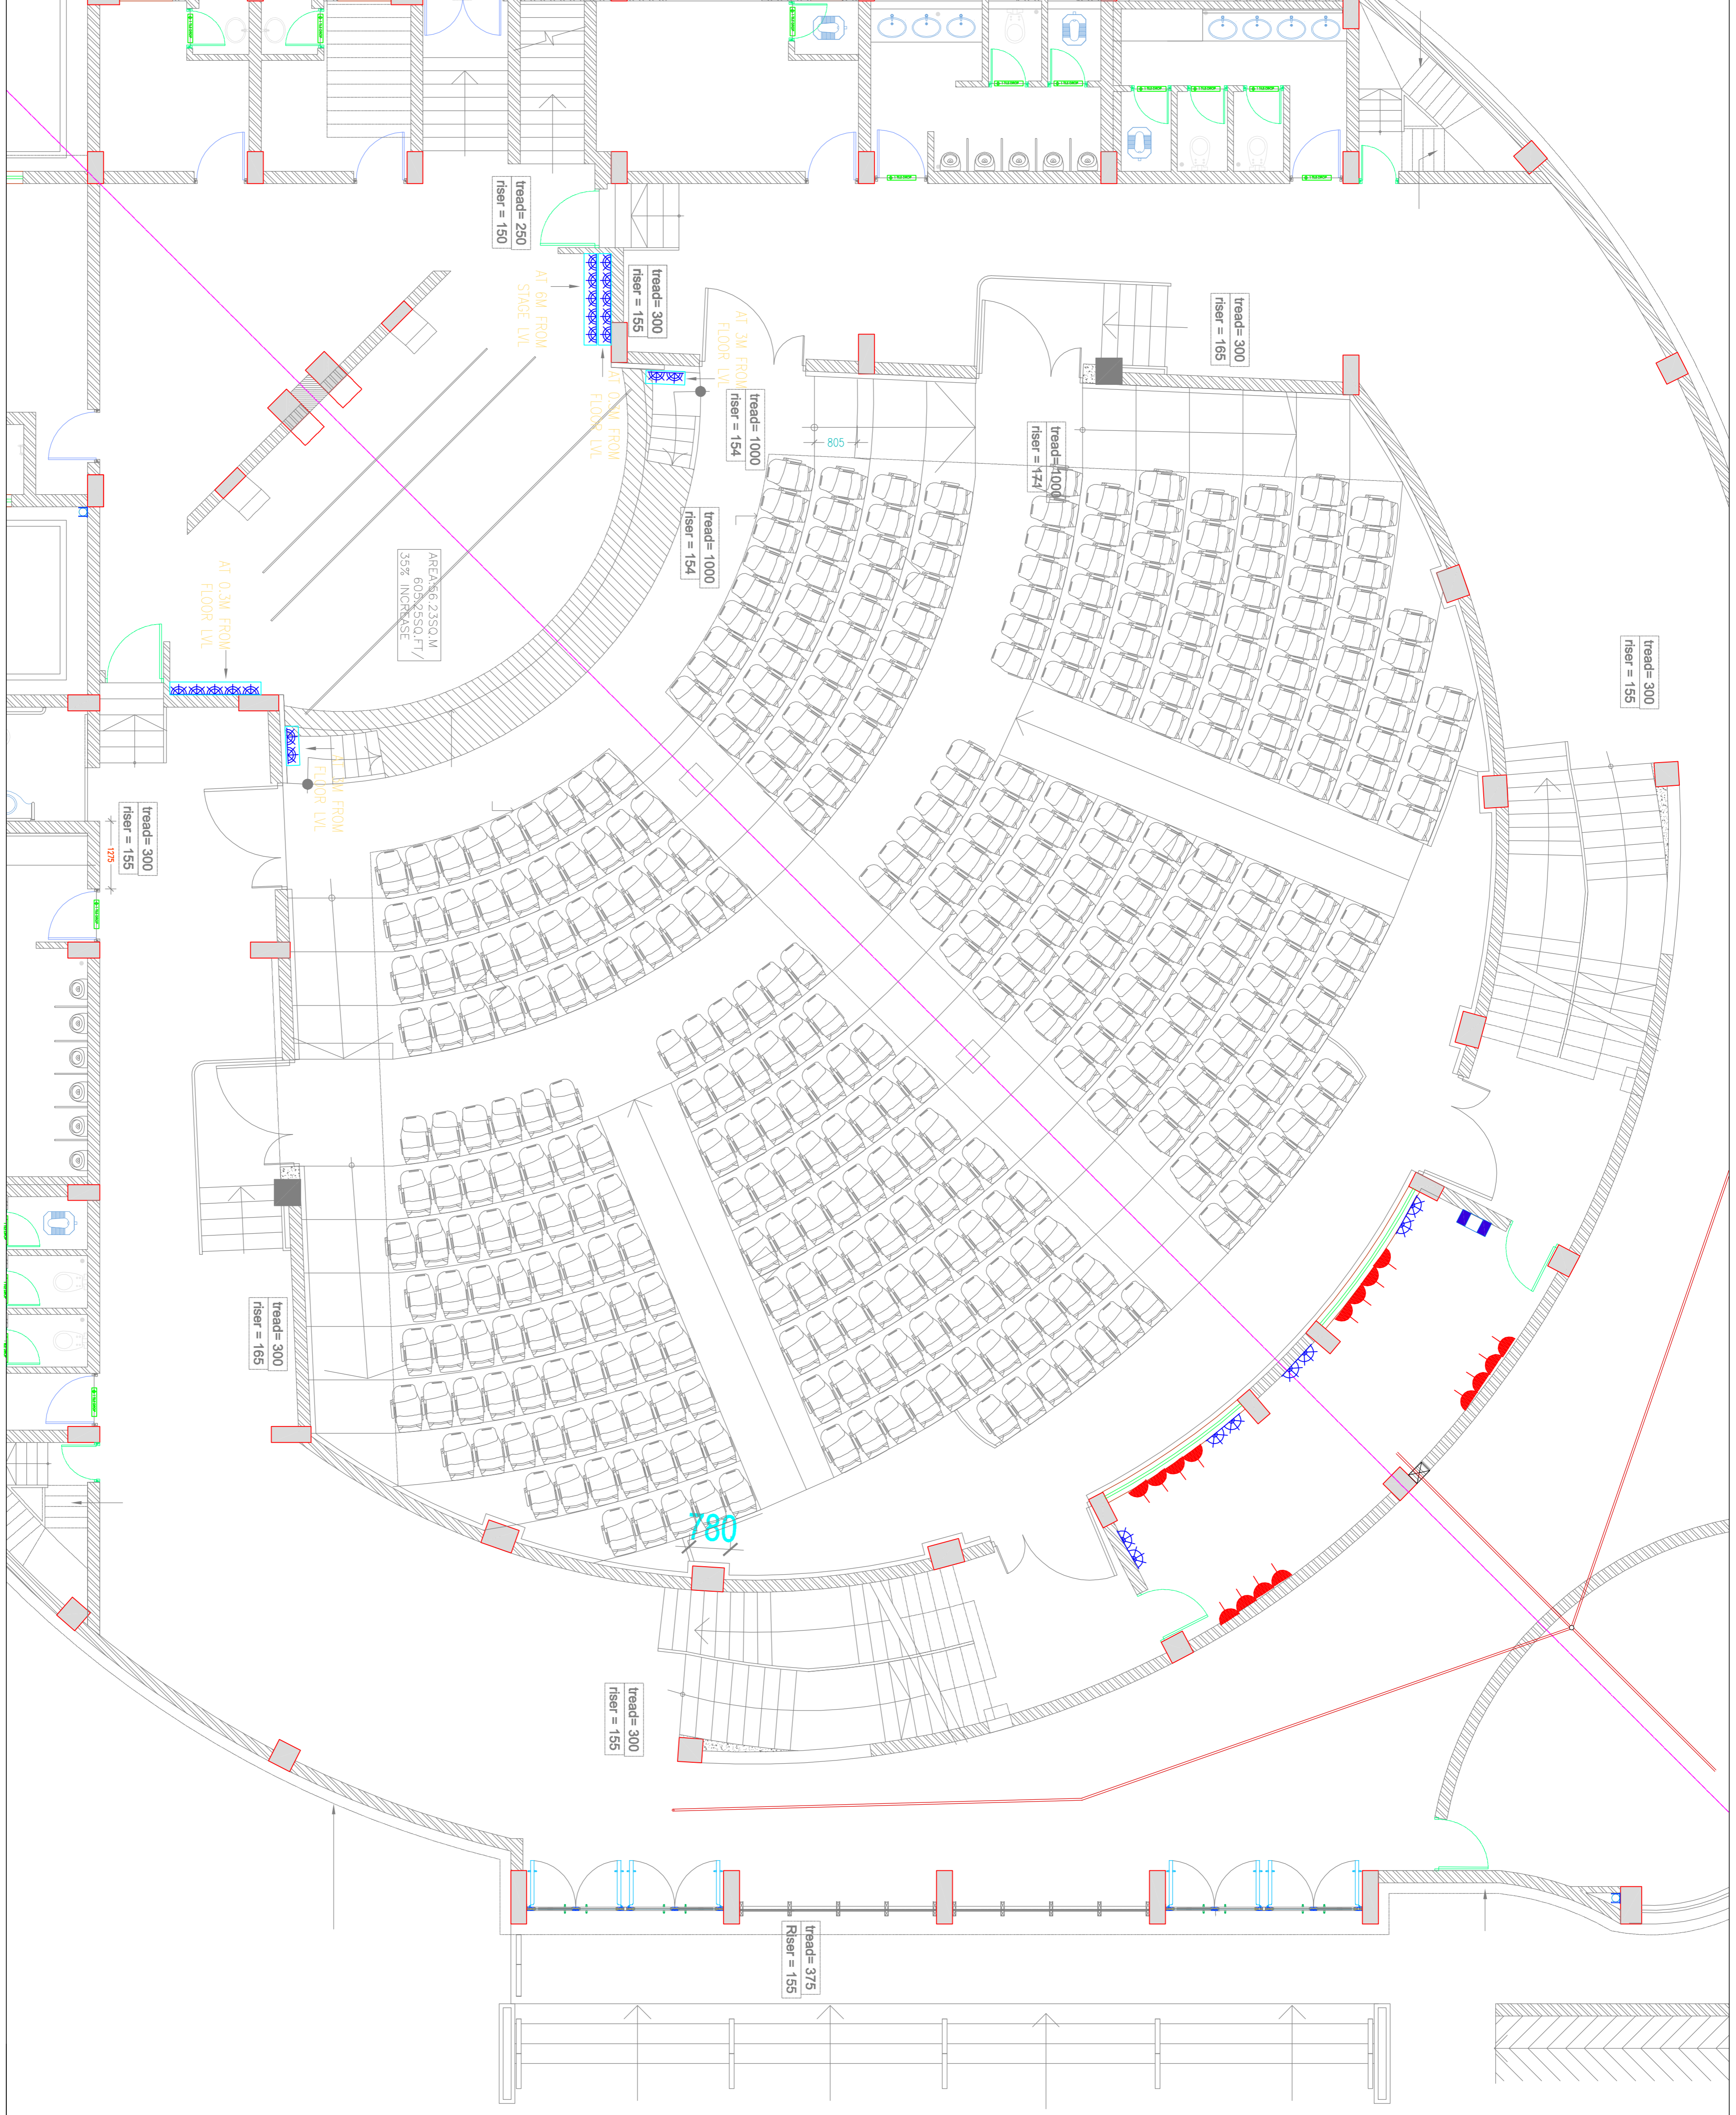


ARCHIVISTA
ENGINEERING PROJECTS PVT. LTD.
OFFICE NO. 201/202, THIRD FLOOR, SAI EMPIRE
BANER, PUNE - 411 045,
PH. (020) 66294444, FAX. (020) 66294699,
WWW.ARCHIVISTAPUNE.COM

PROPOSED COMPLEX FOR CONFERENCE AND LECTURES HALLS - IITM PUNE

 
 
 

RESPONSIBLE
STAGE T- TENDER DRAWING

DRAWING TITLE P.A SYSTEM POWER SOCKET LAYOUT			
SCALE 1:100	FORMAT A1	DRAWN BY TS	CHECKED BY IITM_EX_PS_CH_FP_001
DRAWING NUMBER IITM_EX_PS_CH_FP_001		DATE OF FIRST ISSUE 18.04.12	DATE OF REVISION
REFERENCE DRAWING NUMBER 			REVISION R0



GROUND FLOOR PLAN

LEGENDS

SYMBOLS	DESCRIPTION	QTY.
	5/15A MODULAR S/S	19
	16A MODULAR S/S	08
	5A MODULAR S/S	16
	UPS POWER DISTRIBUTION BOARD (UPSDB)	01